


ALL ELECTRICAL WORK SHALL CONVEY TO CHAIRMAN, HAWAII COUNTY CODE AND INSTALLATION AND MATERIALS SHALL BE IN ACCORDANCE WITH THE NATIONAL ELECTRICAL CODE

THIS WORK WAS PREPARED BY ME UNDER MY PERSONAL SUPERVISION AND CONSTRUCTION OF THIS PROJECT WILL BE UNDER MY OBSERVATION
WALLACE T. OKI, P.E., INC.
ELECTRICAL ENGINEERING
1000 KALIA ROAD, SUITE 200
HONOLULU, HAWAII 96819
WFO REF. NO. 82008149

ELECTRICAL WORK

Drawn by:	Job Number:	2804-00
Created by:	Scale:	AS NOTED
Plot Date:	Issue Date:	17 OCT 08

PERMIT ISSUE
E-11

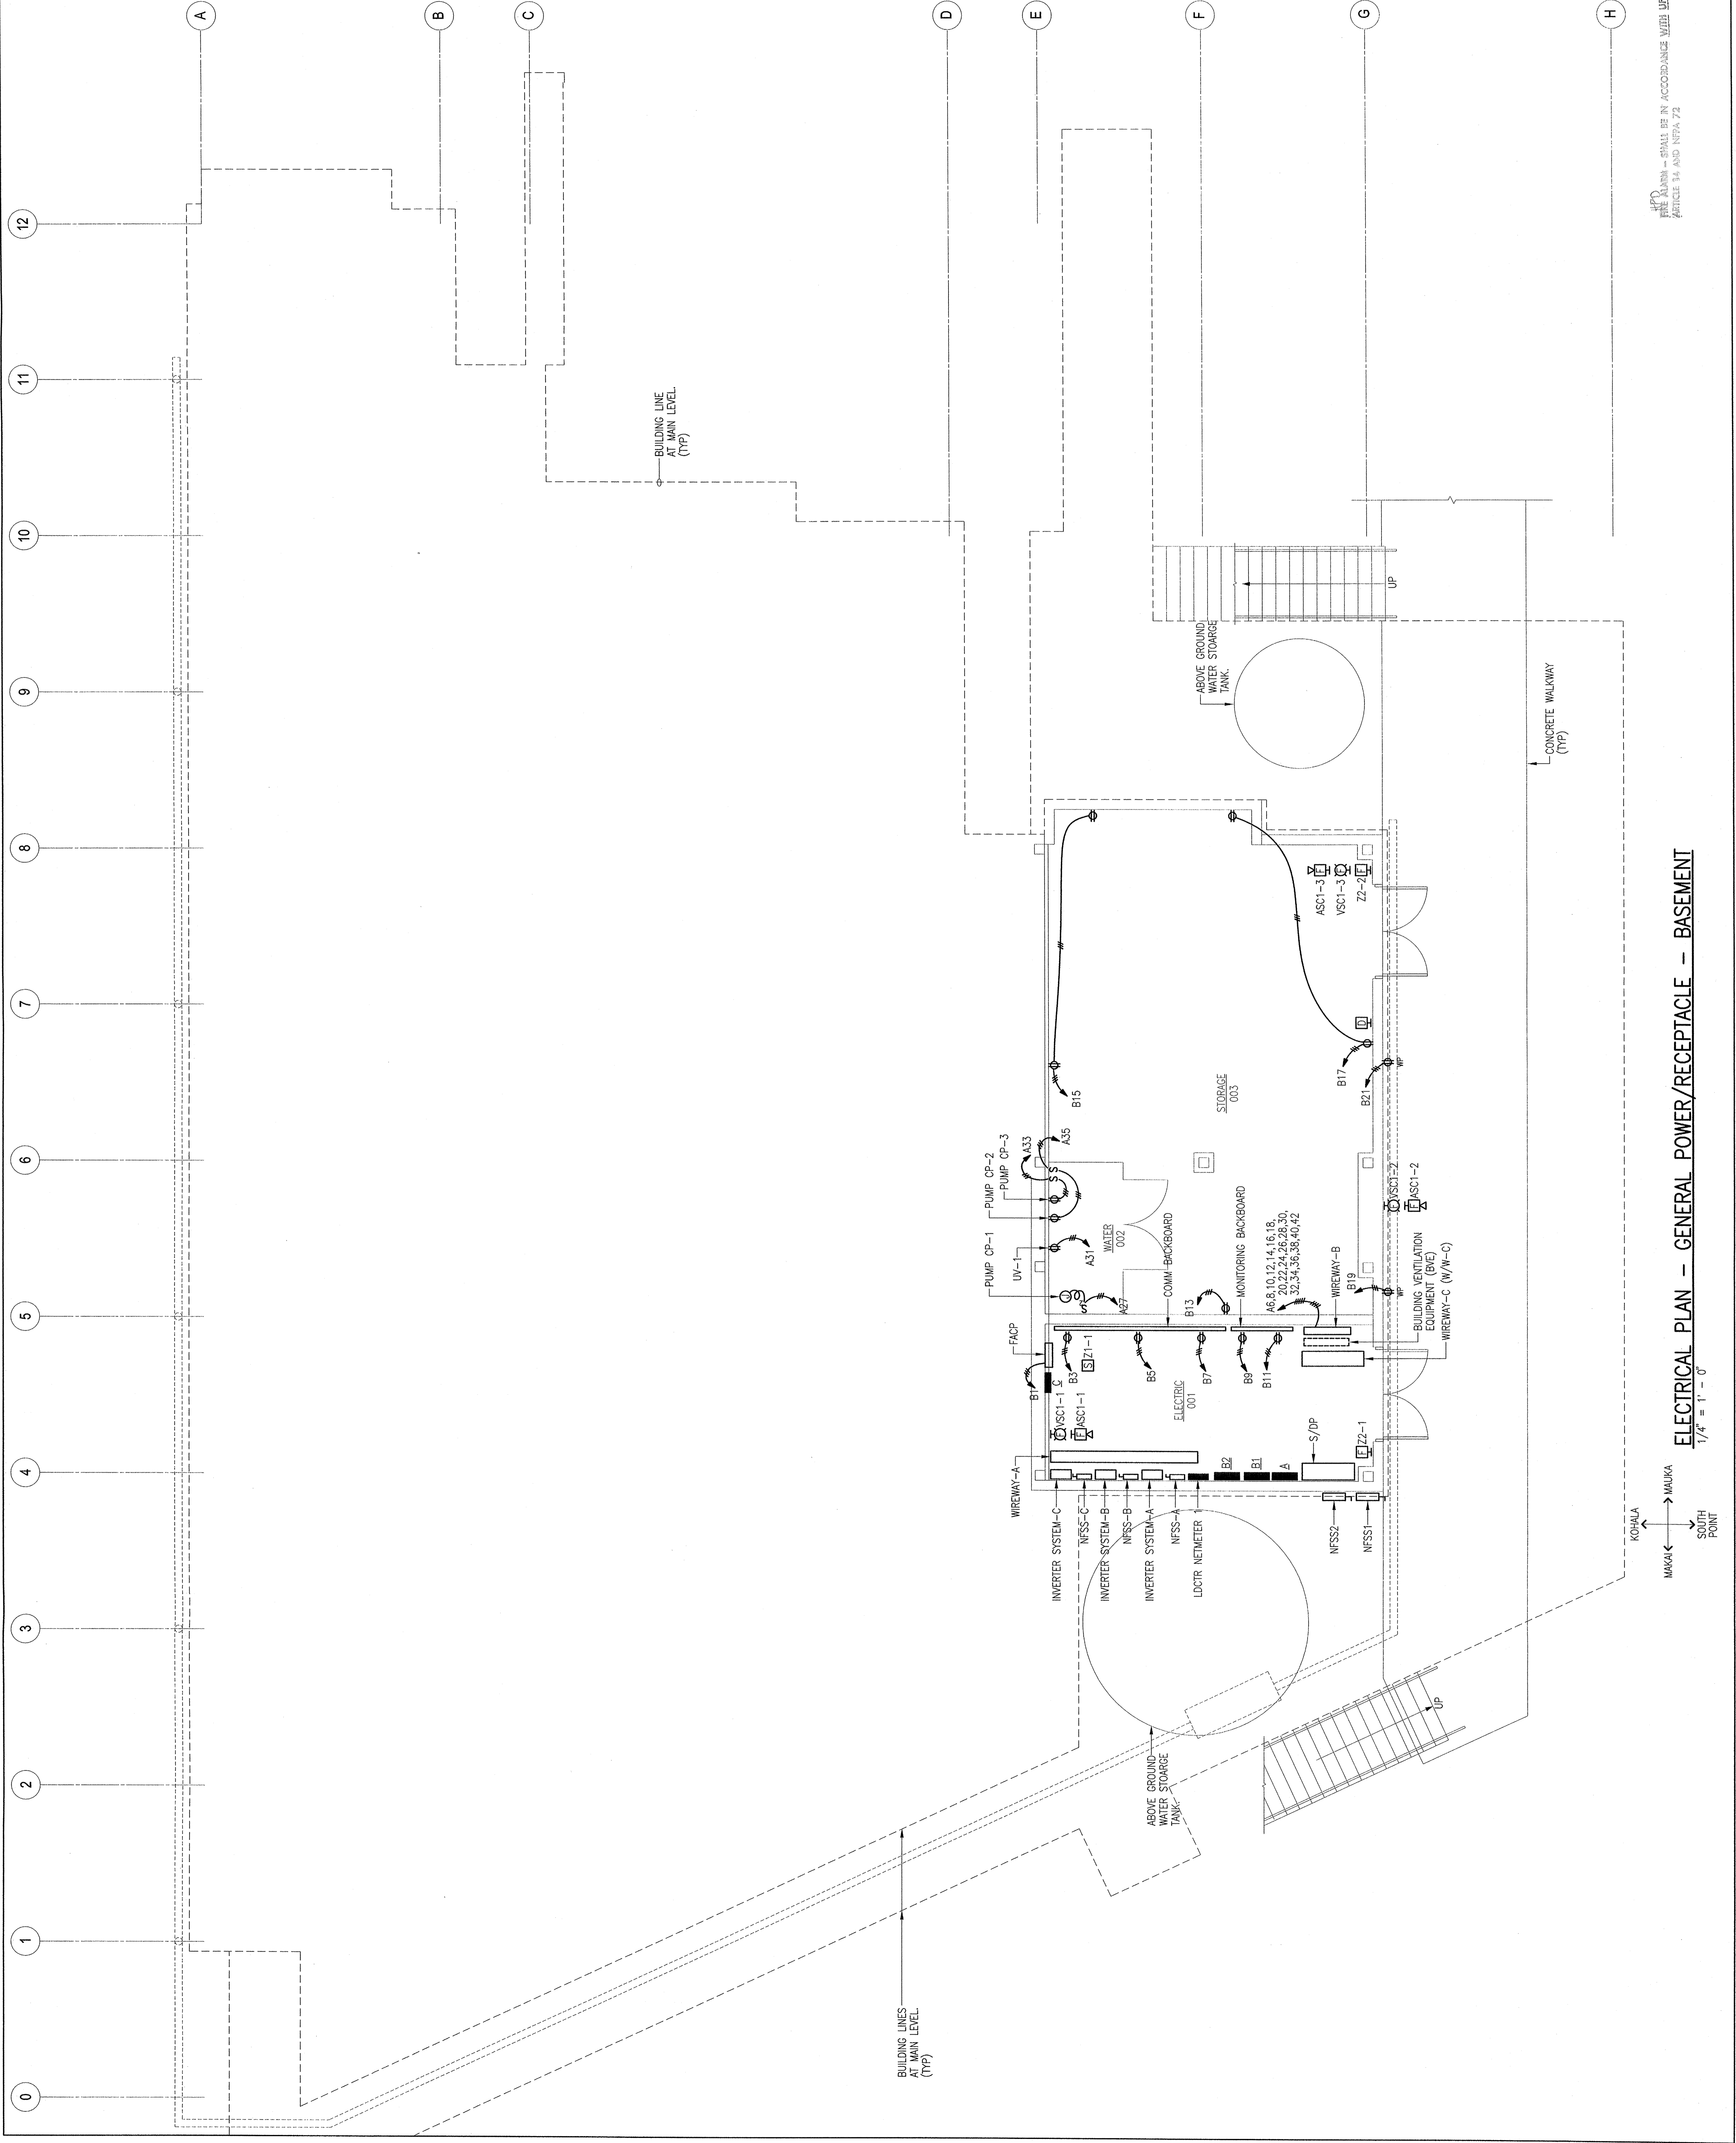

THIS DRAWING SHALL BE IN ACCORDANCE WITH USC ARTICLE 14 AND NFPA 72

ELECTRICAL PLAN - GENERAL POWER/RECEPTACLE - BASEMENT
1/4" = 1'-0"

