



ALL ELECTRICAL WORK SHALL CONFORM TO  
CHAP. 9, HAWAII COUNTY CODE, AND  
INSTALLATION AND MATERIALS SHALL BE  
IN ACCORDANCE WITH THE NATIONAL  
ELECTRICAL CODE

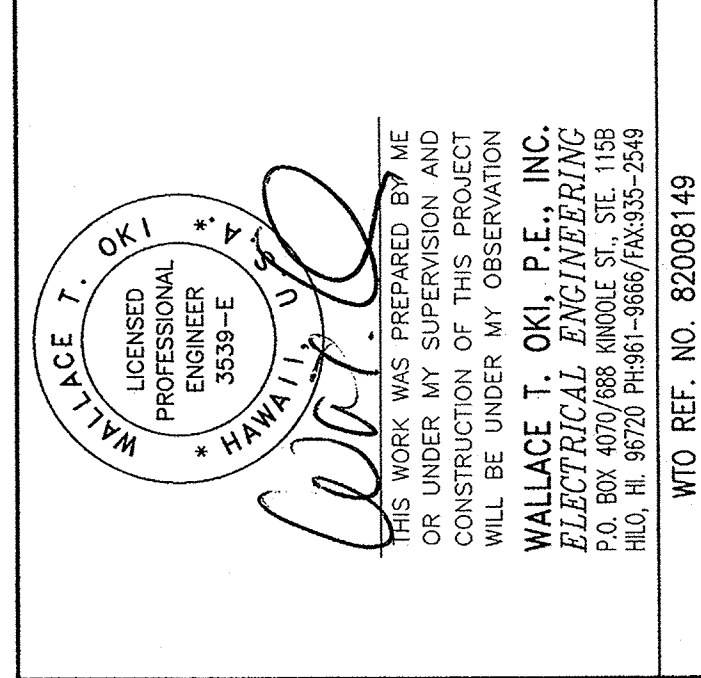

THIS WORK WAS PREPARED BY ME  
OR UNDER MY CLOSE PERSONAL  
SUPERVISION AND I AM A REGISTERED  
CONTRACTOR OF THIS PROJECT  
WILL BE UNDER MY OBSERVATION  
**WALLACE T. OKI, P.E., INC.**  
ELECTRICAL ENGINEERING  
1000 ALA MOANA BLVD., SUITE 1000  
HONOLULU, HAWAII 96813-2498  
WTO REF. NO. 82038149


**ELECTRICAL WORK**

Drawn by:	Job Number:	2804-00
Checked by:	Scale:	AS NOTED
Plot Date:	Issue Date:	17 OCT 08
PERMIT ISSUE		

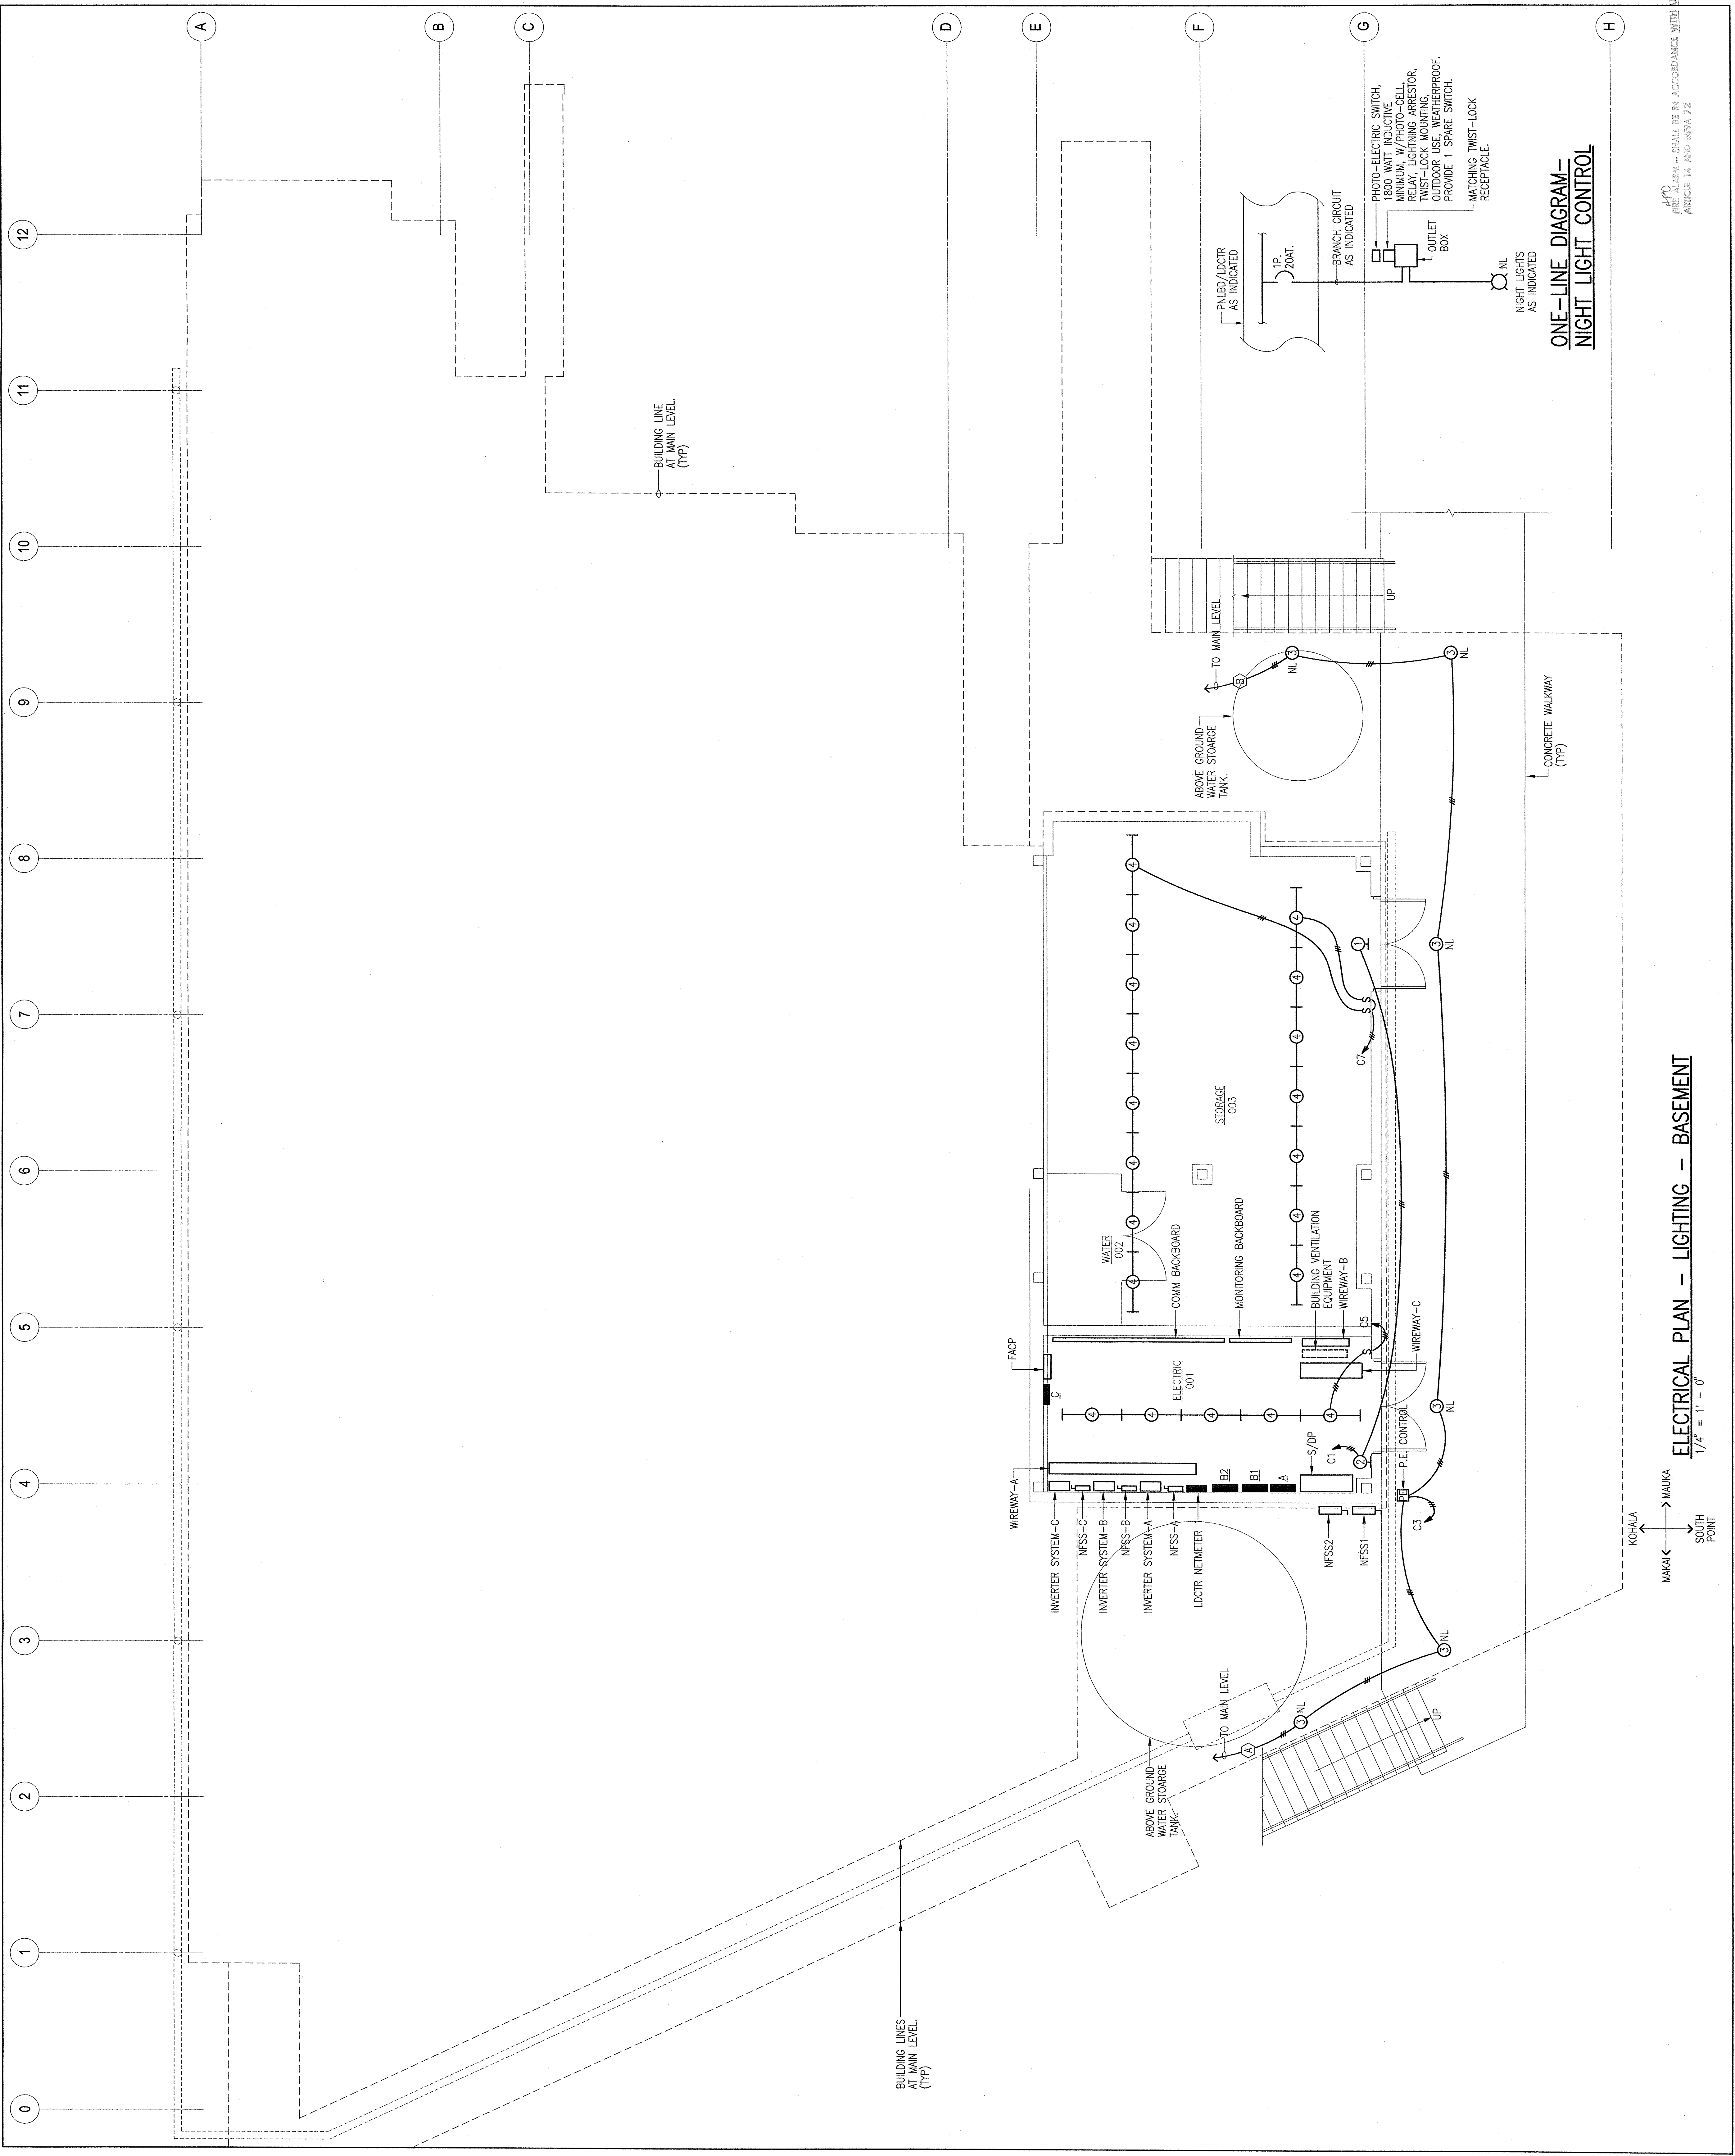

**ONE-LINE DIAGRAM -  
NIGHT LIGHT CONTROL**

**ELECTRICAL PLAN - LIGHTING - BASEMENT**  
1/4" = 1' - 0"

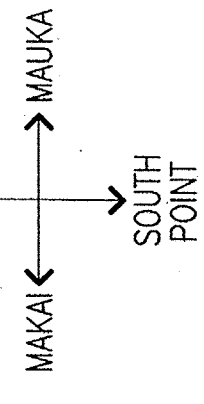

SEE PLAN - SHALL BE IN ACCORDANCE WITH  
ARTICLE 14 AND NEPA 73