


ALL ELECTRICAL WORK SHALL CONFORM TO
CHAPTER 9, NATIONAL ELECTRICAL CODE
AND ALL MATERIALS SHALL BE
IN ACCORDANCE WITH THE NATIONAL
ELECTRICAL CODE

WALLACE T. OKI
LICENSED PROFESSIONAL ENGINEER
ELECTRICAL
NO. 10052
MAUI, HI
THIS WORK WAS PREPARED BY ME
OR UNDER MY SUPERVISION AND
CONSTRUCTION OF THIS PROJECT
WILL BE UNDER MY OBSERVATION
WALLACE T. OKI, PE
ELECTRICAL ENGINEERING
P.O. BOX 4070 688 MAUIA ST. SE. 1158
H.O. HI. 96720 PH:81-8666/FAX:81-2548
WTD REF. NO. 82008149

ELECTRICAL WORK

Drawn by:	Job Number:	2804.00
Checked by:	Scale:	AS NOTED
Per Date:	Issue Date:	17 OCT 08
PERMIT ISSUE		

E-14

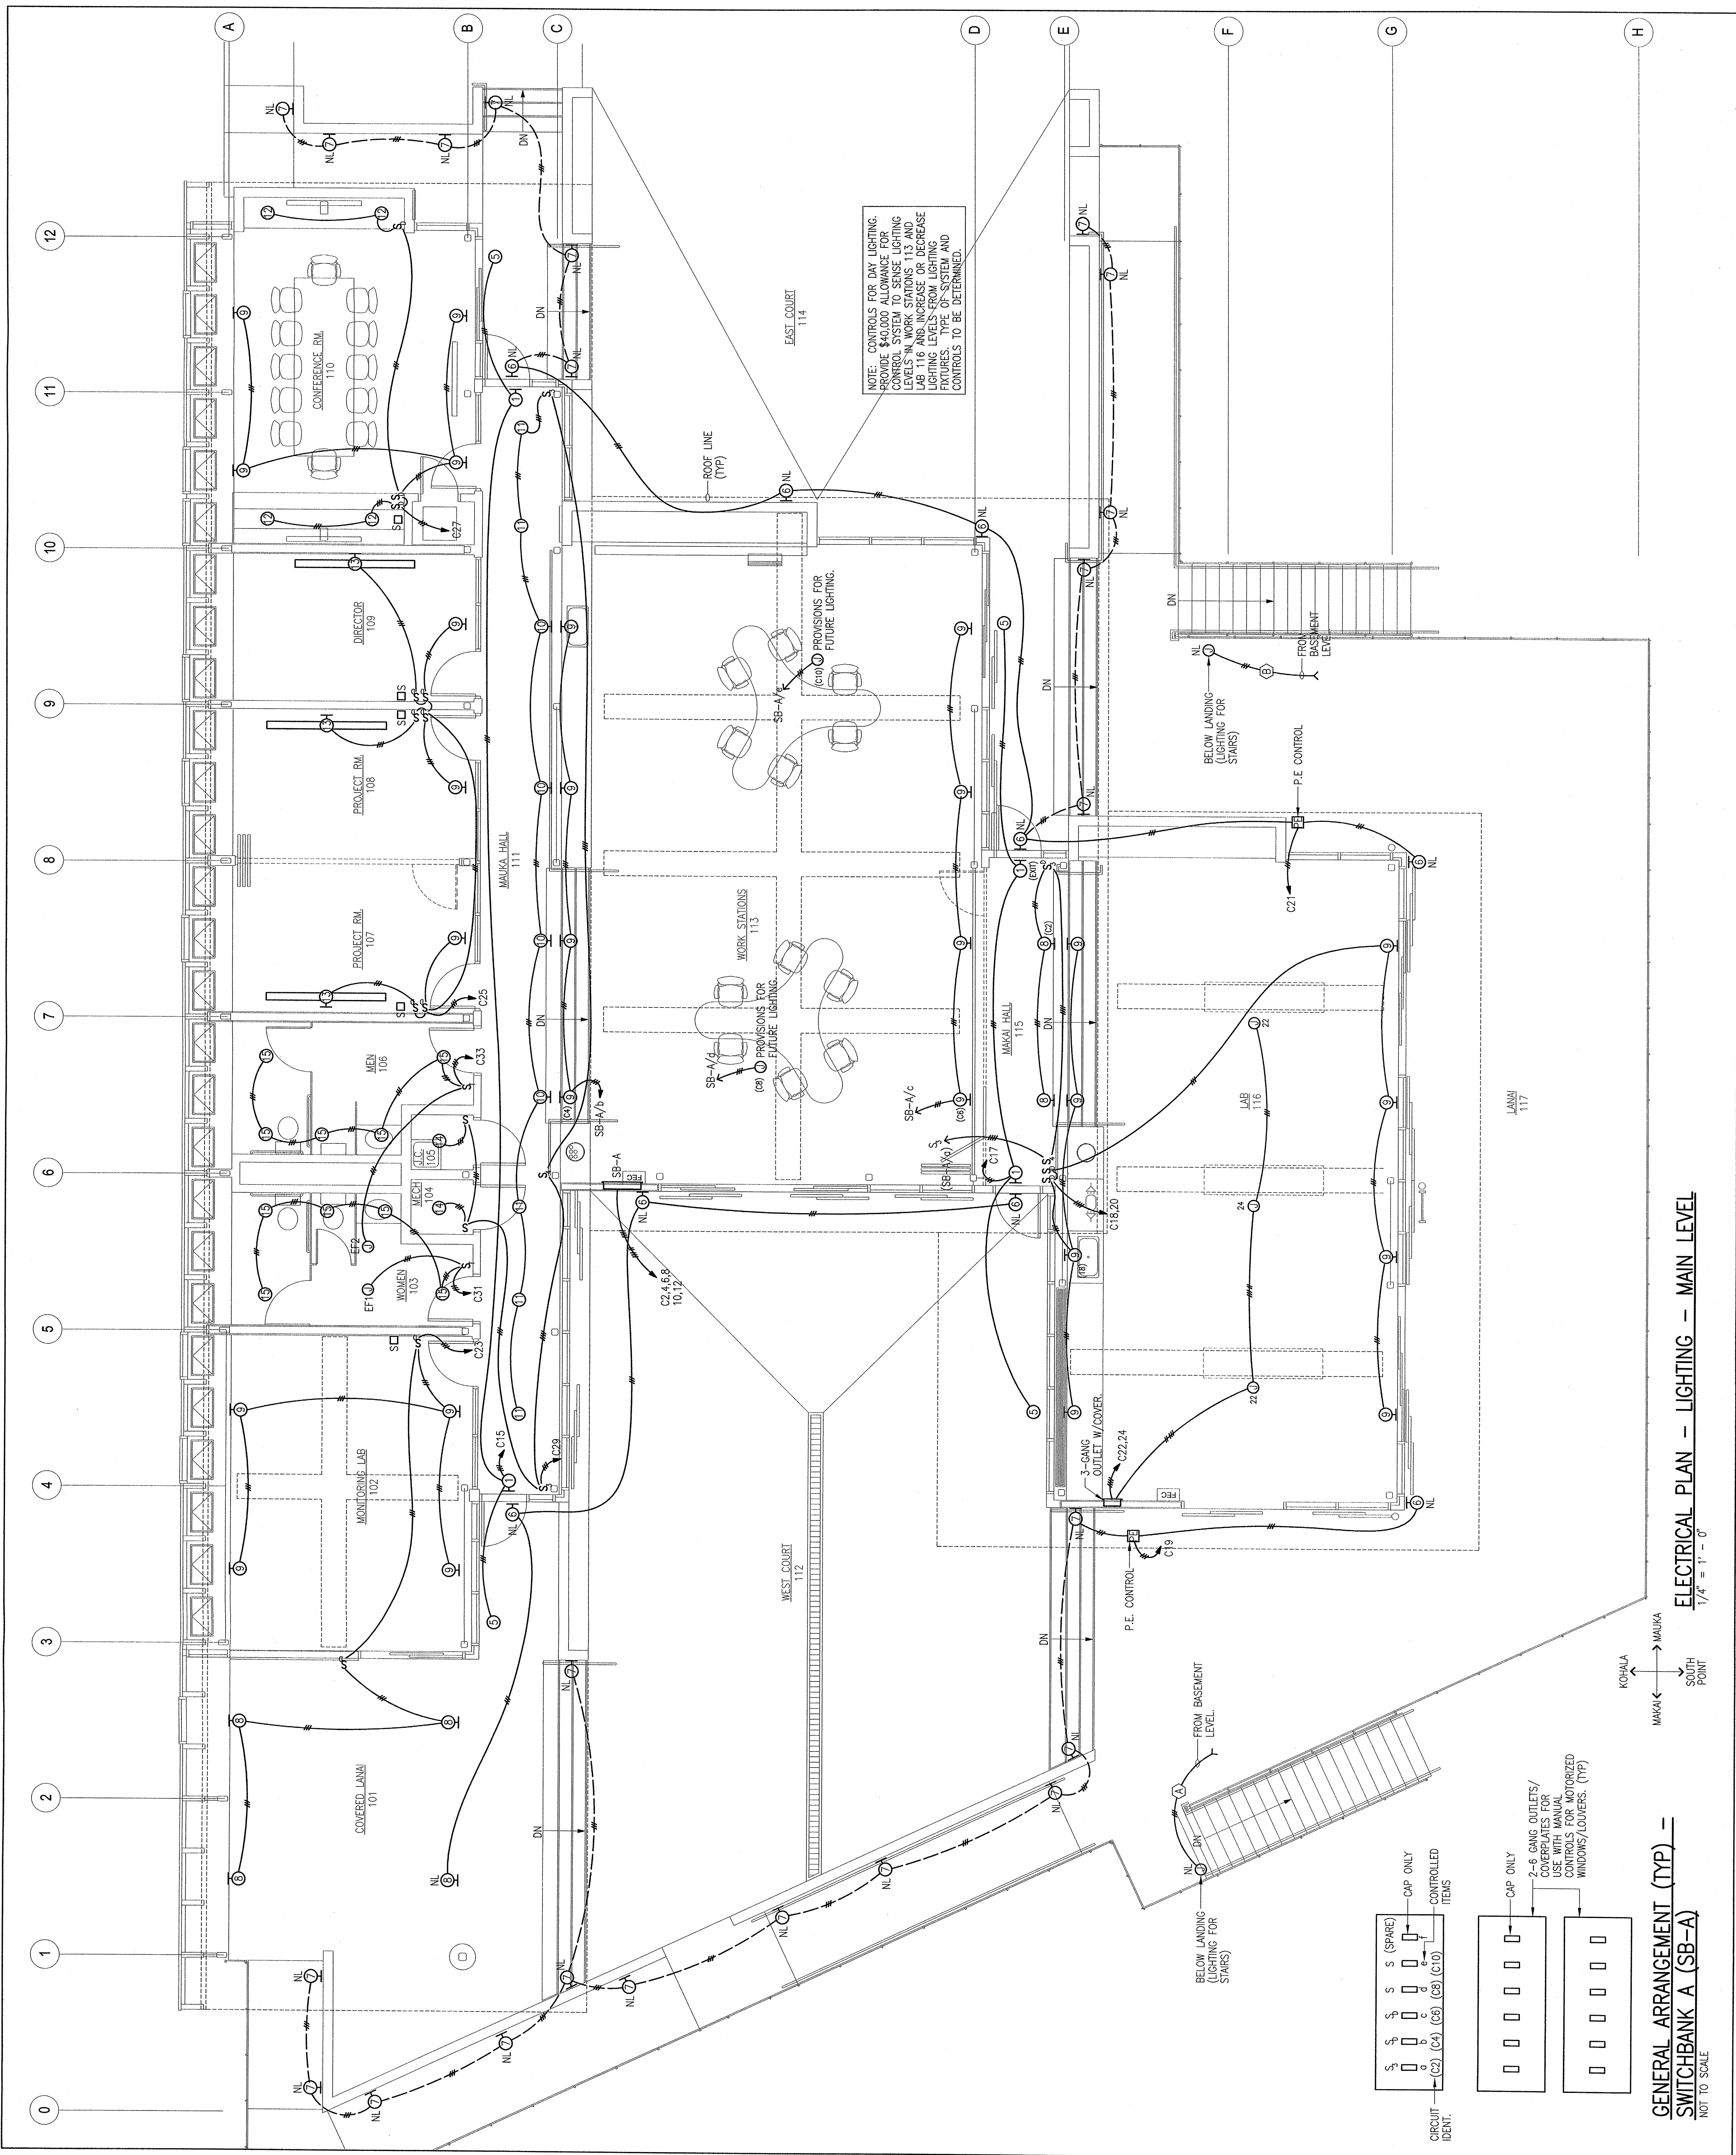

ELECTRICAL PLAN - LIGHTING - MAIN LEVEL
1/4" = 1' - 0"

GENERAL ARRANGEMENT (TYP) SWITCHBANK A (SB-A)
NOT TO SCALE