



ALL ELECTRICAL WORK SHALL COMPLY TO THE NATIONAL ELECTRICAL CODE (NEC) AND ALL INSTALLATION AND MATERIALS SHALL BE IN ACCORDANCE WITH THE NATIONAL ELECTRICAL CODE

WALLACE T. OKI
LICENSED PROFESSIONAL ENGINEER
3339-E
HAWAII
THIS WORK WAS PREPARED BY ME OR UNDER MY CLOSE PERSONAL SUPERVISION AND I AM AWARE OF ALL THE REQUIREMENTS OF THIS PROJECT AND I AM NOT PROVIDING ANY OTHER INFORMATION THAT WILL BE UNDER MY OBSERVATION.
WALLACE T. OKI, P.E., INC.
ELECTRICAL ENGINEERING
P.O. BOX 28
MAKAHA, HI 96710
TEL: 808.961.9866 FAX: 808.961.9866
WTO REF. NO. 8208149

| | |
|------------------------|-----------------------|
| ELECTRICAL WORK | |
| Drawn by: | Job Number: 2894-00 |
| Checked by: | Scale: AS NOTED |
| Plot Date: | Issue Date: 17 OCT 08 |
| PERMIT ISSUE | E-7 |

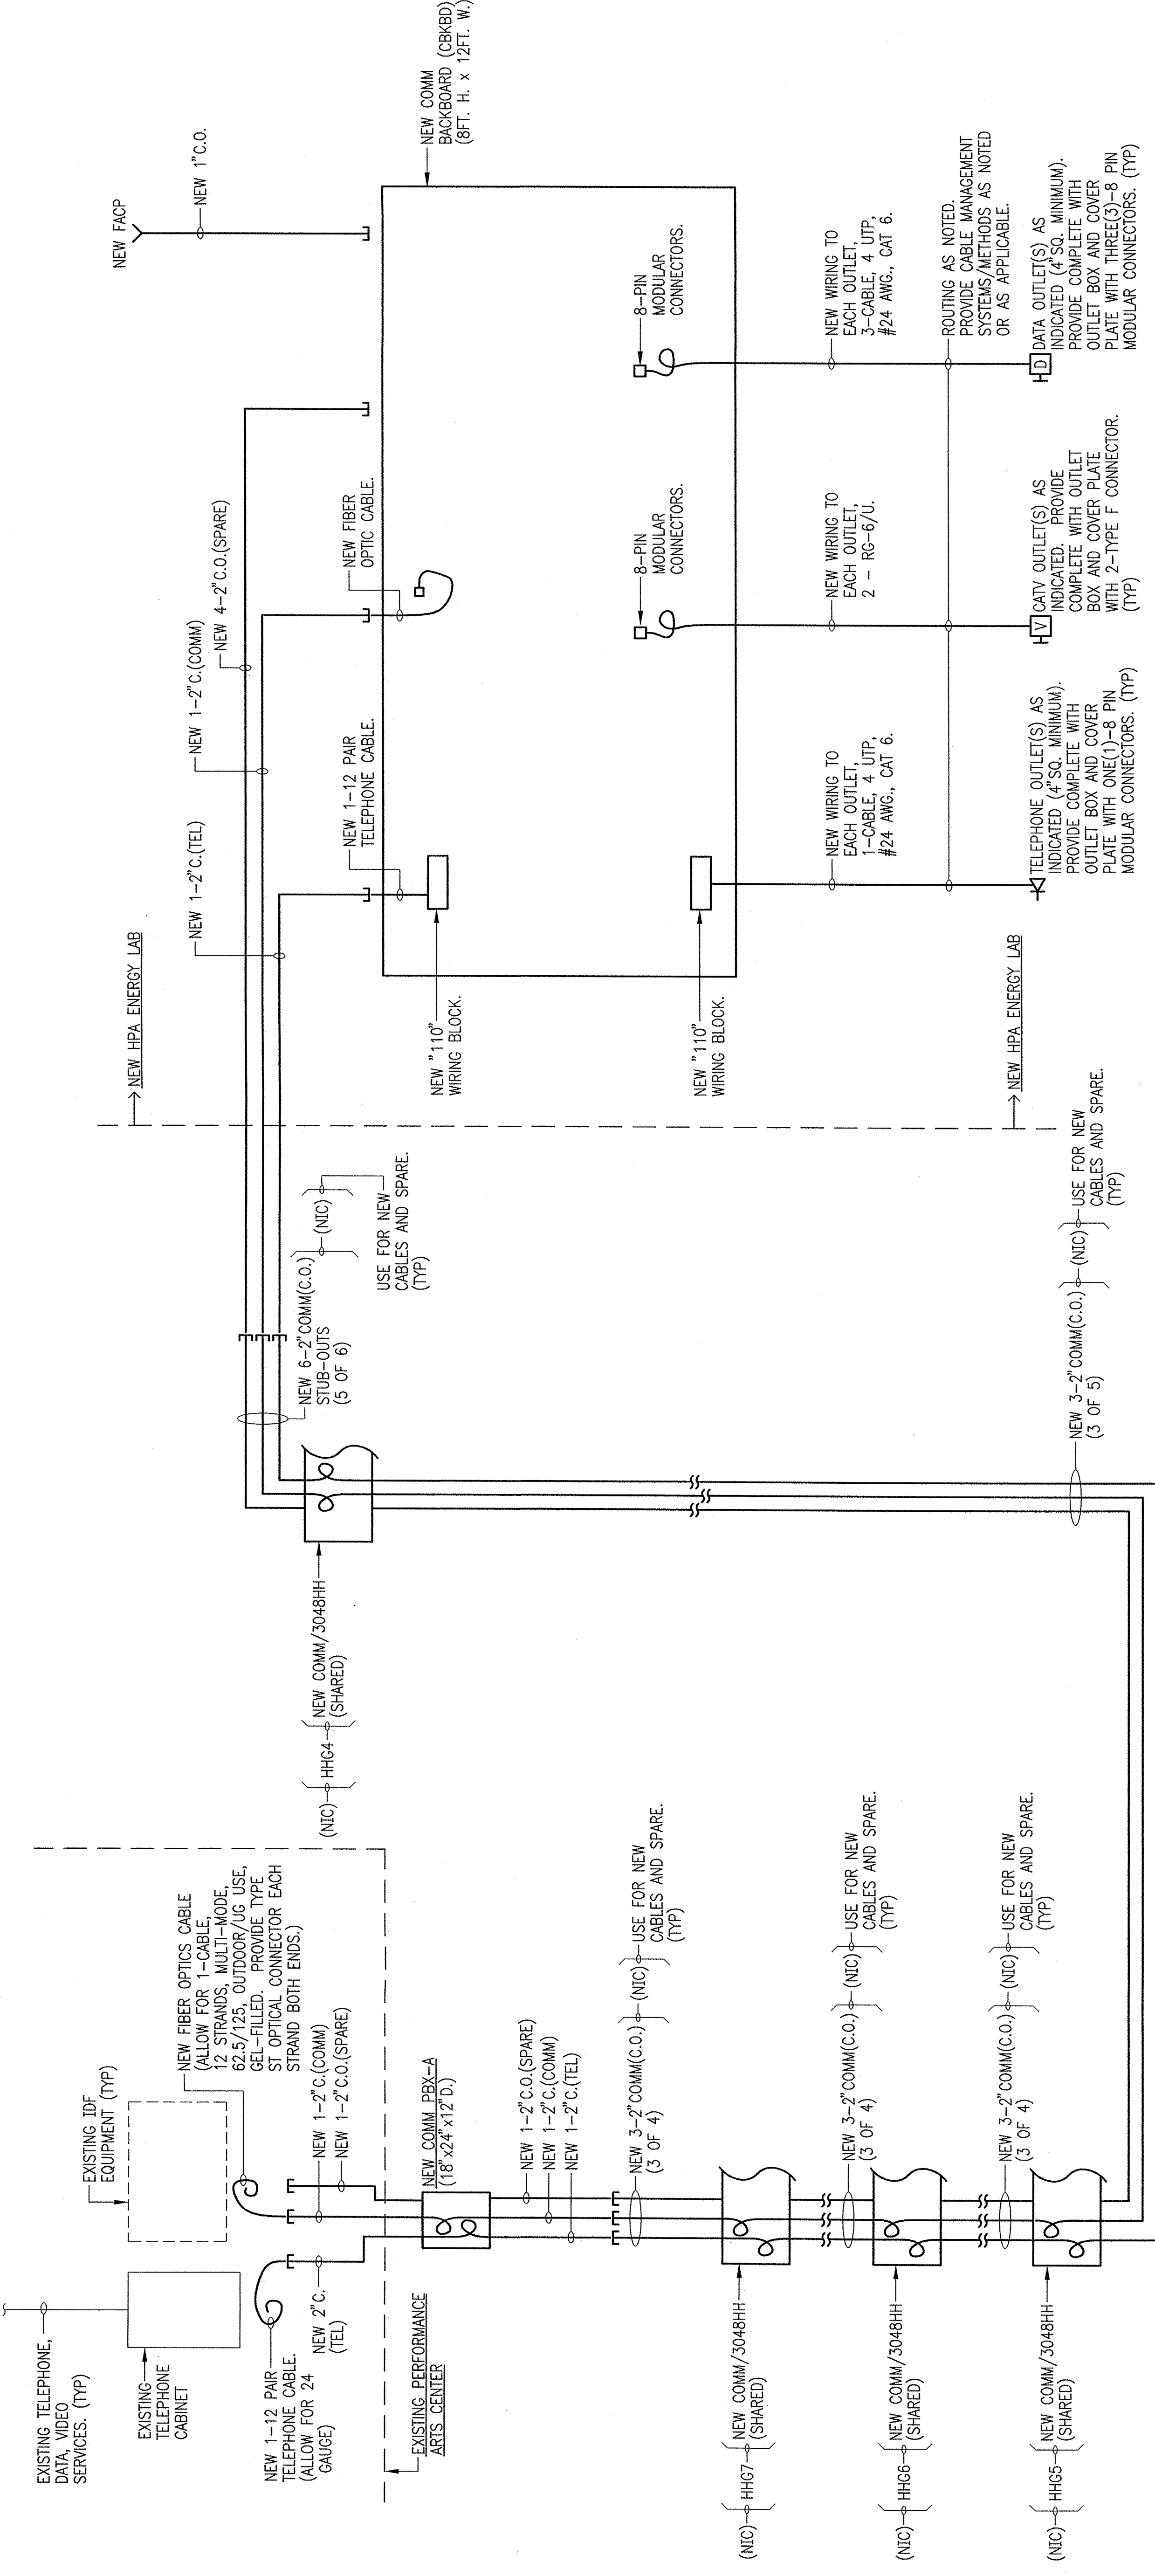

ONE-LINE DIAGRAM -- COMMUNICATIONS -- HPA ENERGY LAB

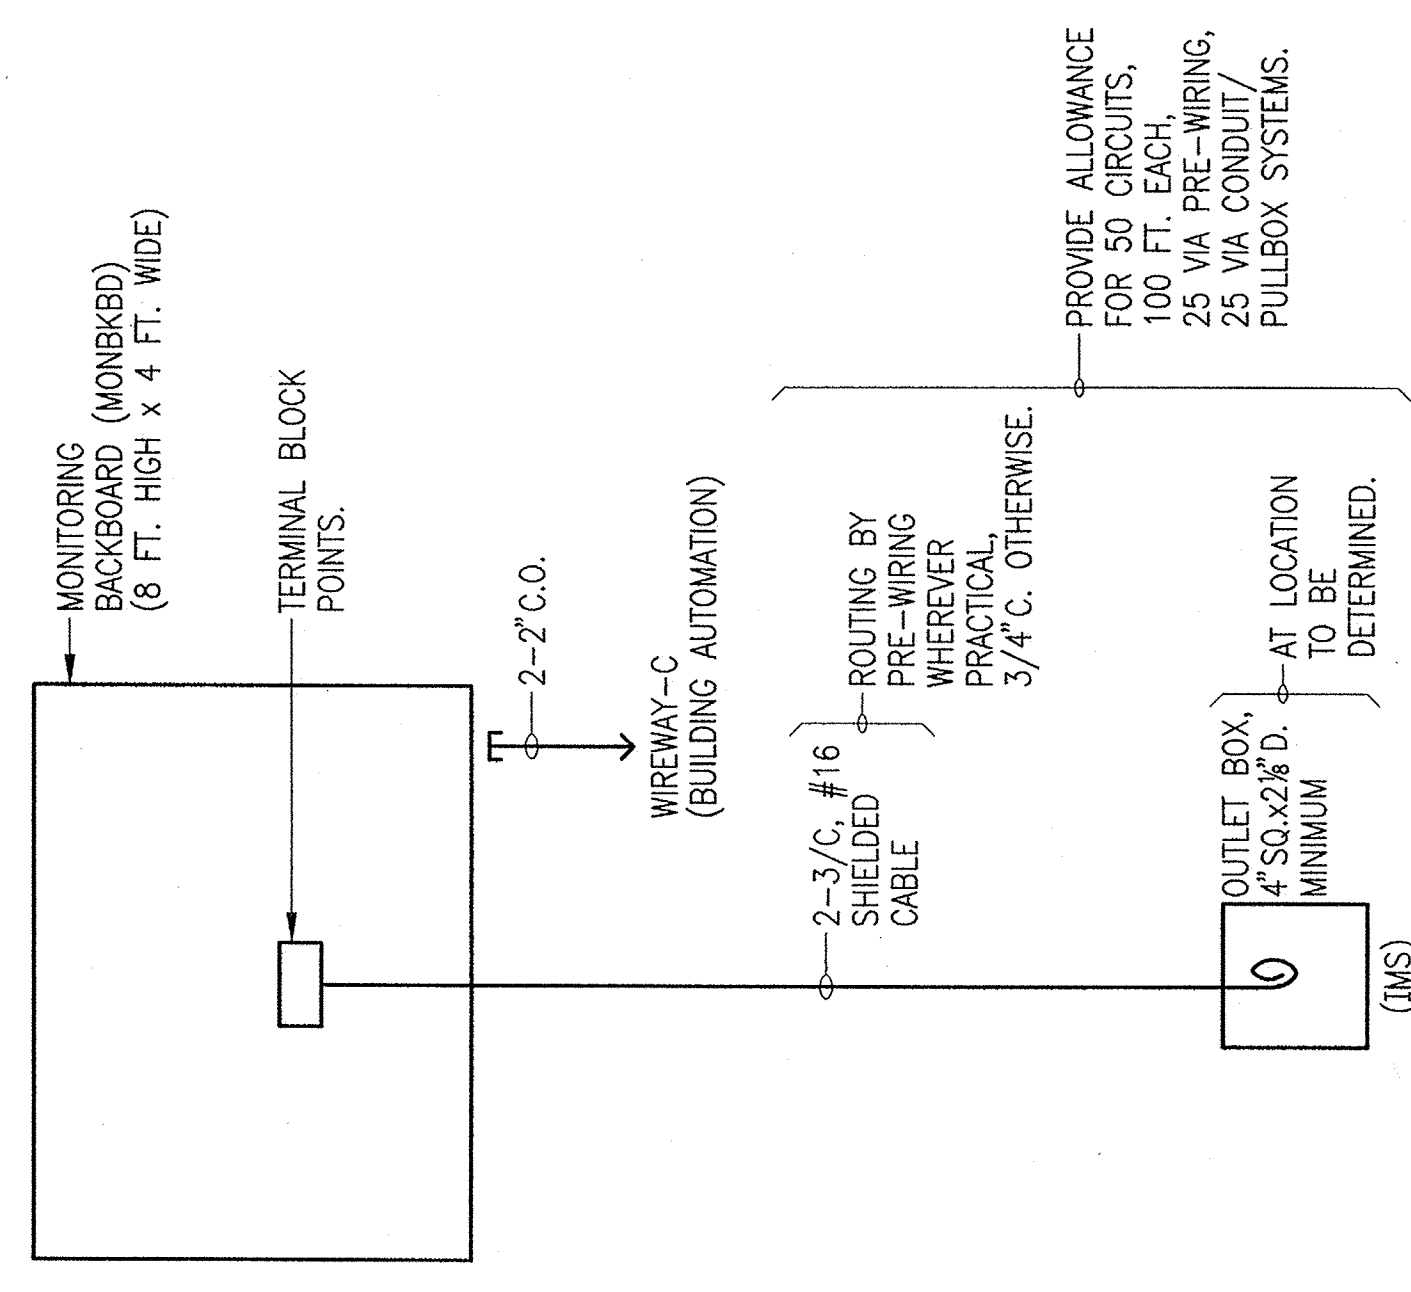

ONE-LINE DIAGRAM -- INFORMATION MONITORING SYSTEM (IMS)