

FLANSBURGH ARCHITECTS

77 North Washington Street
Boston, Massachusetts 02114
617.367.3970 tel
617.720.7873 fax
www.flarchitects.com
Architecture
Master Planning
Space Planning
Interior Design

PROJECT MANAGEMENT
Pa'ahana Enterprises, LLC
P.O. Box 109
Kealahou, HI 9675
808.323.2304 tel/fax


SUSTAINABILITY
Buro Happold Consulting Engineers PC
100 Broadway, 23rd Floor
New York, NY 10005
212.334.2025 tel

CIVIL ENGINEERING
Belt Collins Hawaii Ltd.
2153 North King Street, Suite 200
Honolulu, Hawaii 96819
808.521.5361 tel
808.538.7819 fax


STRUCTURAL ENGINEERING
Walter Vorfeld & Associates
10 Uliana Street
Makawao, Maui, HI 96768
808.572.3535 tel
808.573.3616 fax

MECHANICAL ENGINEERING
Hakalau Engineering
PO Box 252
Hakalau, Hawaii 96710
808.961.6206 tel

ELECTRICAL ENGINEERING
Wallace T. Oki, PE, Inc.

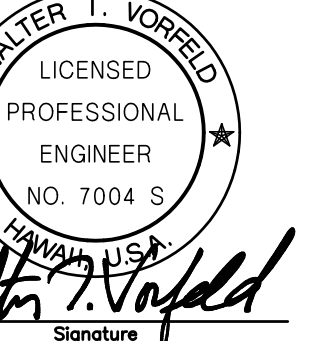

This work was performed by me or under my supervision and construction of this project will be under my observation (Observation of construction as defined in section 16-15-2 of the rules and regulations of the Board of Professional Engineers, Architects and Surveyors of the State of Hawaii).
Date: 4/26/09

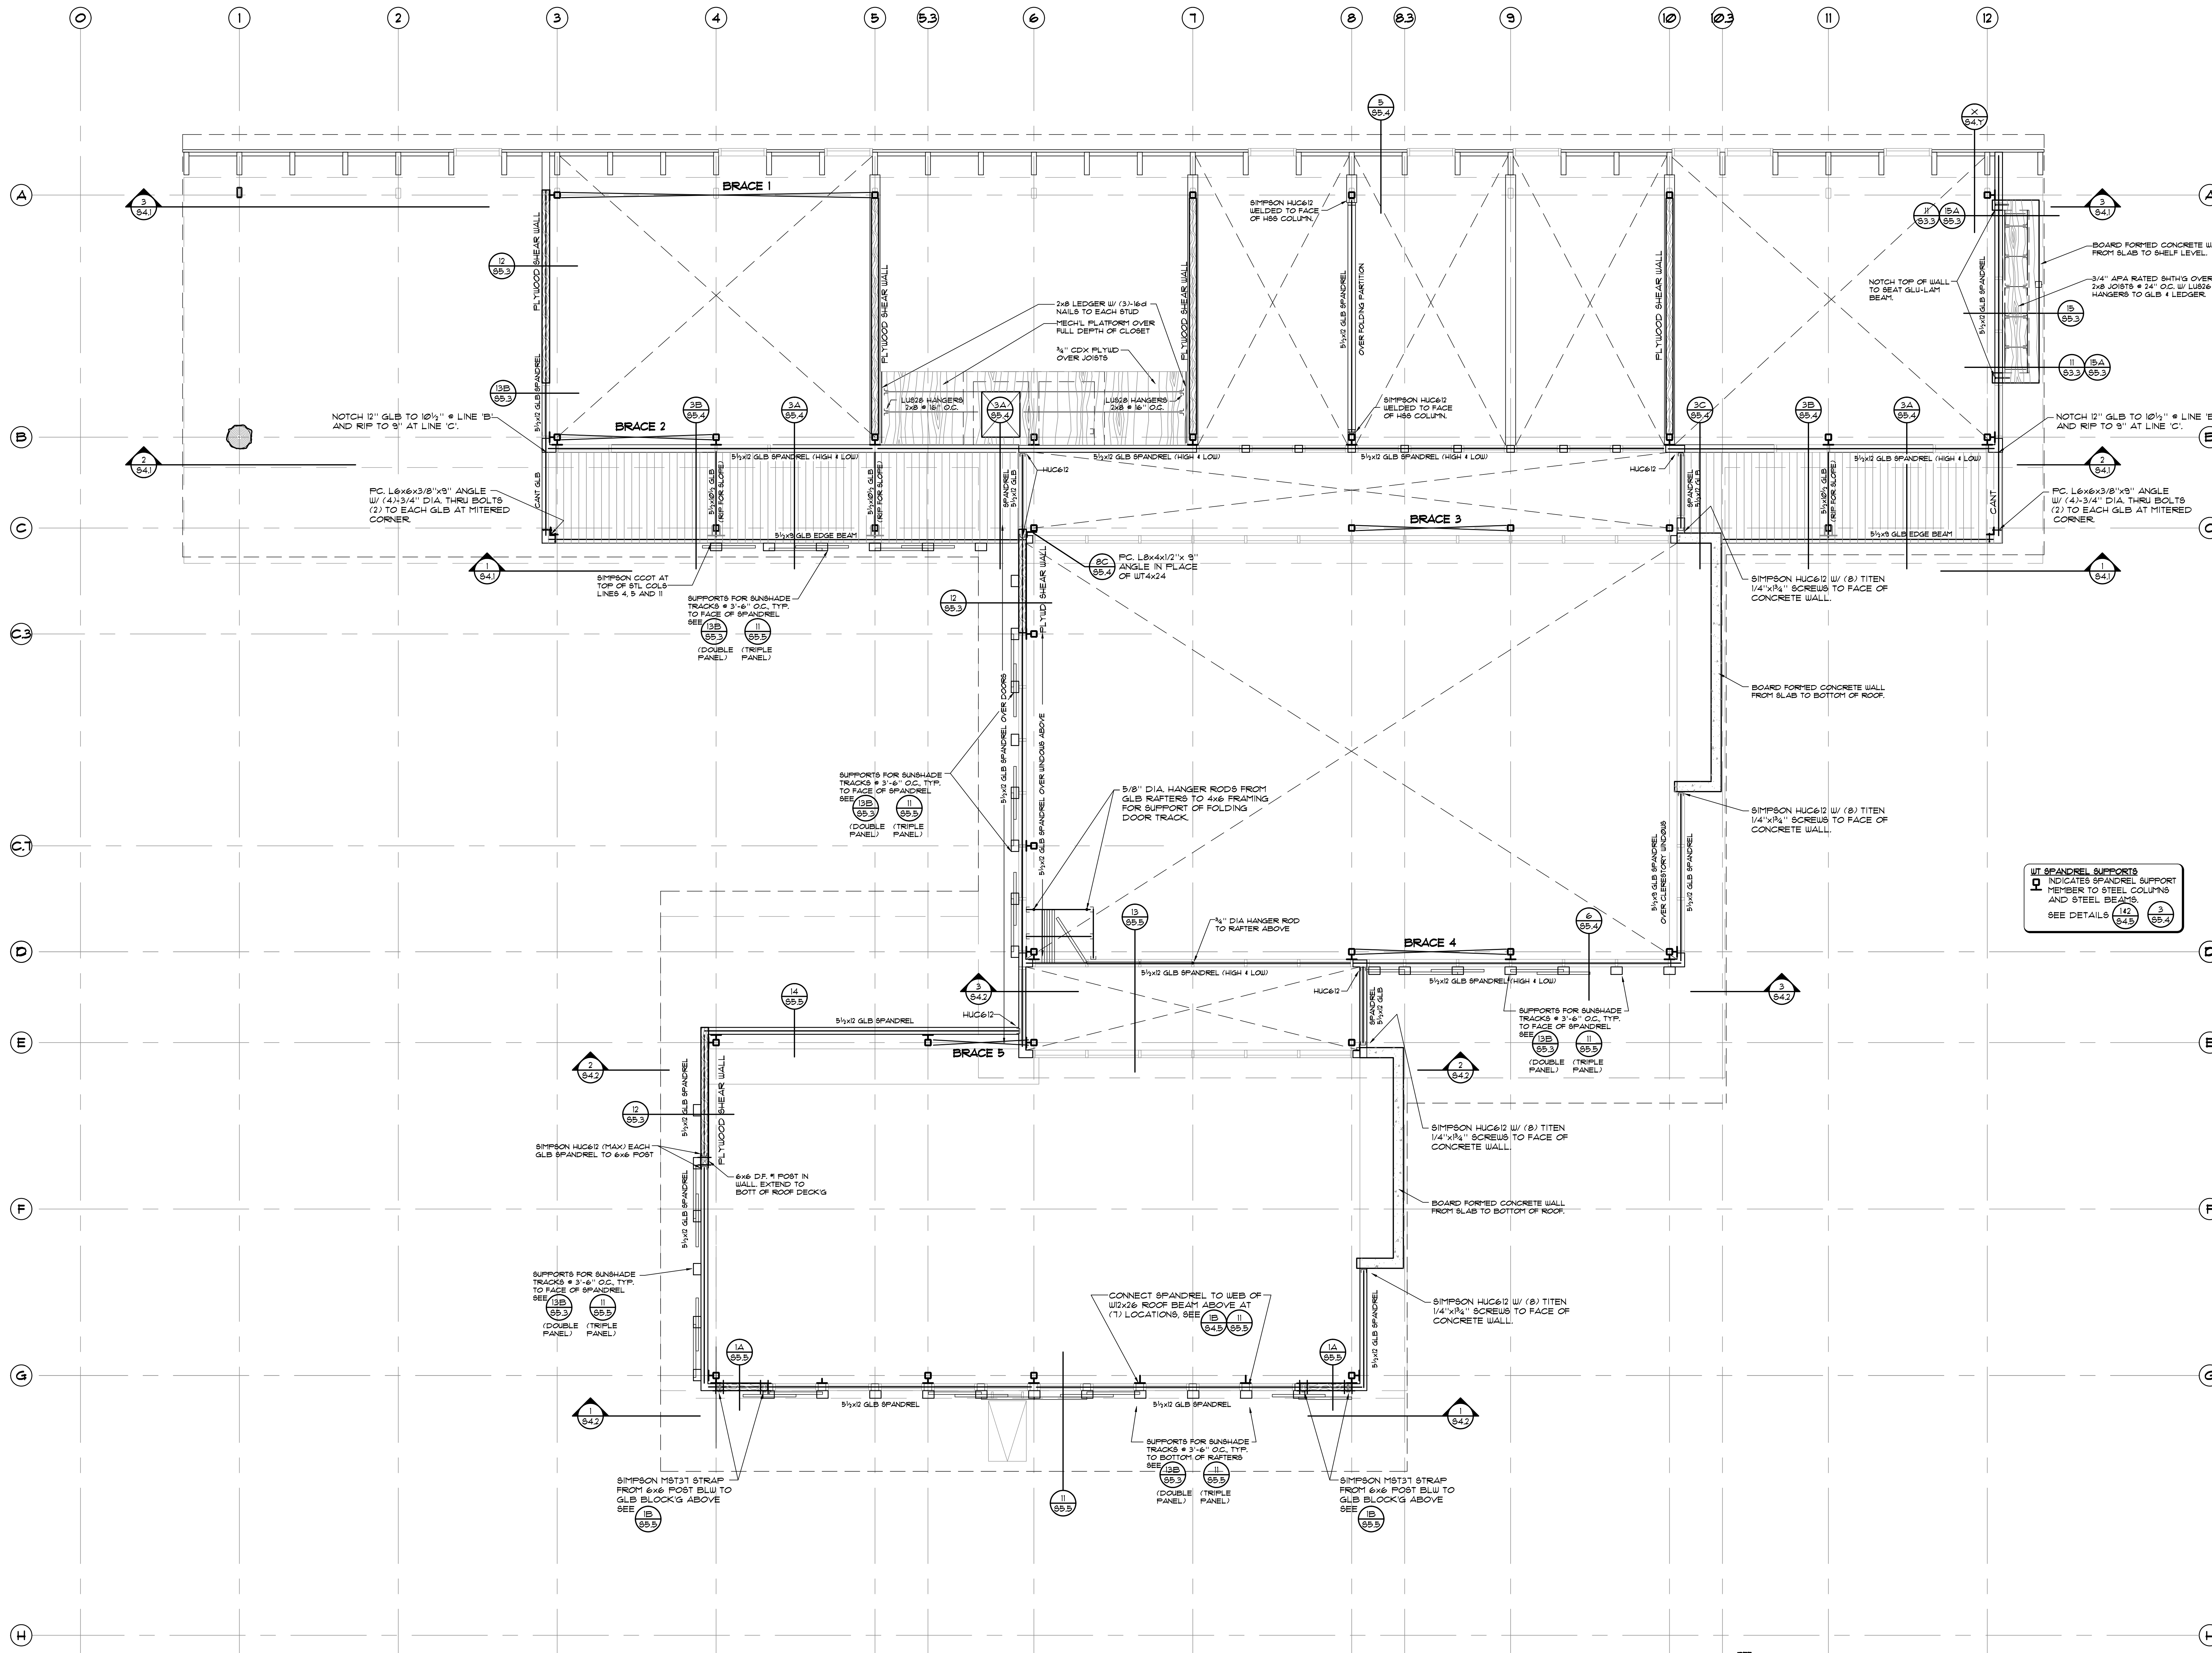

WT SPANDREL SUPPORTS
INDICATES SPANDREL SUPPORT MEMBER TO STEEL COLLUMNS AND STEEL BEAMS.
SEE DETAILS (12) (14) (16) (18) (20)

PERMIT SET	1/19/09

FRAMING PLAN @ CLERESTORY LEVEL

Drawn by: WTV, RD, KC	Job Number: WVA-28012
Checked by: WTV, RD, KC	Scale: AS NOTED
PERMIT SET	Date: 01/19/2009

**S
2.3**

FRAMING PLAN @ CLERESTORY LEVEL
SCALE: 1/4" = 1'-0"