

ENERGY LAB

Hawai'i
Preparatory
Academy

Kamuela, Hawaii

FLANSBURGH ARCHITECTS

77 North Washington Street
Boston, Massachusetts 02114
617.367.3970 tel
617.720.7873 fax
www.flansburgh.com

Architecture
Master Planning
Space Planning
Interior Design

PROJECT MANAGEMENT

Pa'ahana Enterprises, LLC
P.O. Box 109
Kealahou, HI 9675
808.323.2304 tel/fax

SUSTAINABILITY

Buro Happold Consulting Engineers PC
100 Broadway, 23rd Floor
New York, NY, 10005
212.334.2025 tel

CIVIL ENGINEERING

Bett Collins Hawaii Ltd.
2153 North King Street, Suite 200
Honolulu, Hawaii 96819
808.521.5361 tel
808.538.7819 fax

STRUCTURAL ENGINEERING


Walter Vorfeld & Associates
10 Ulana Street
Makawao, Maui, HI 96768
808.572.3535 tel
808.573.3616 fax

MECHANICAL ENGINEERING

Hakalau Engineering
PO Box 252
Hakalau, Hawaii 96710
808.961.6206 tel

ELECTRICAL ENGINEERING

Wallace T. Oki, PE, Inc.
808.961.9666 x22

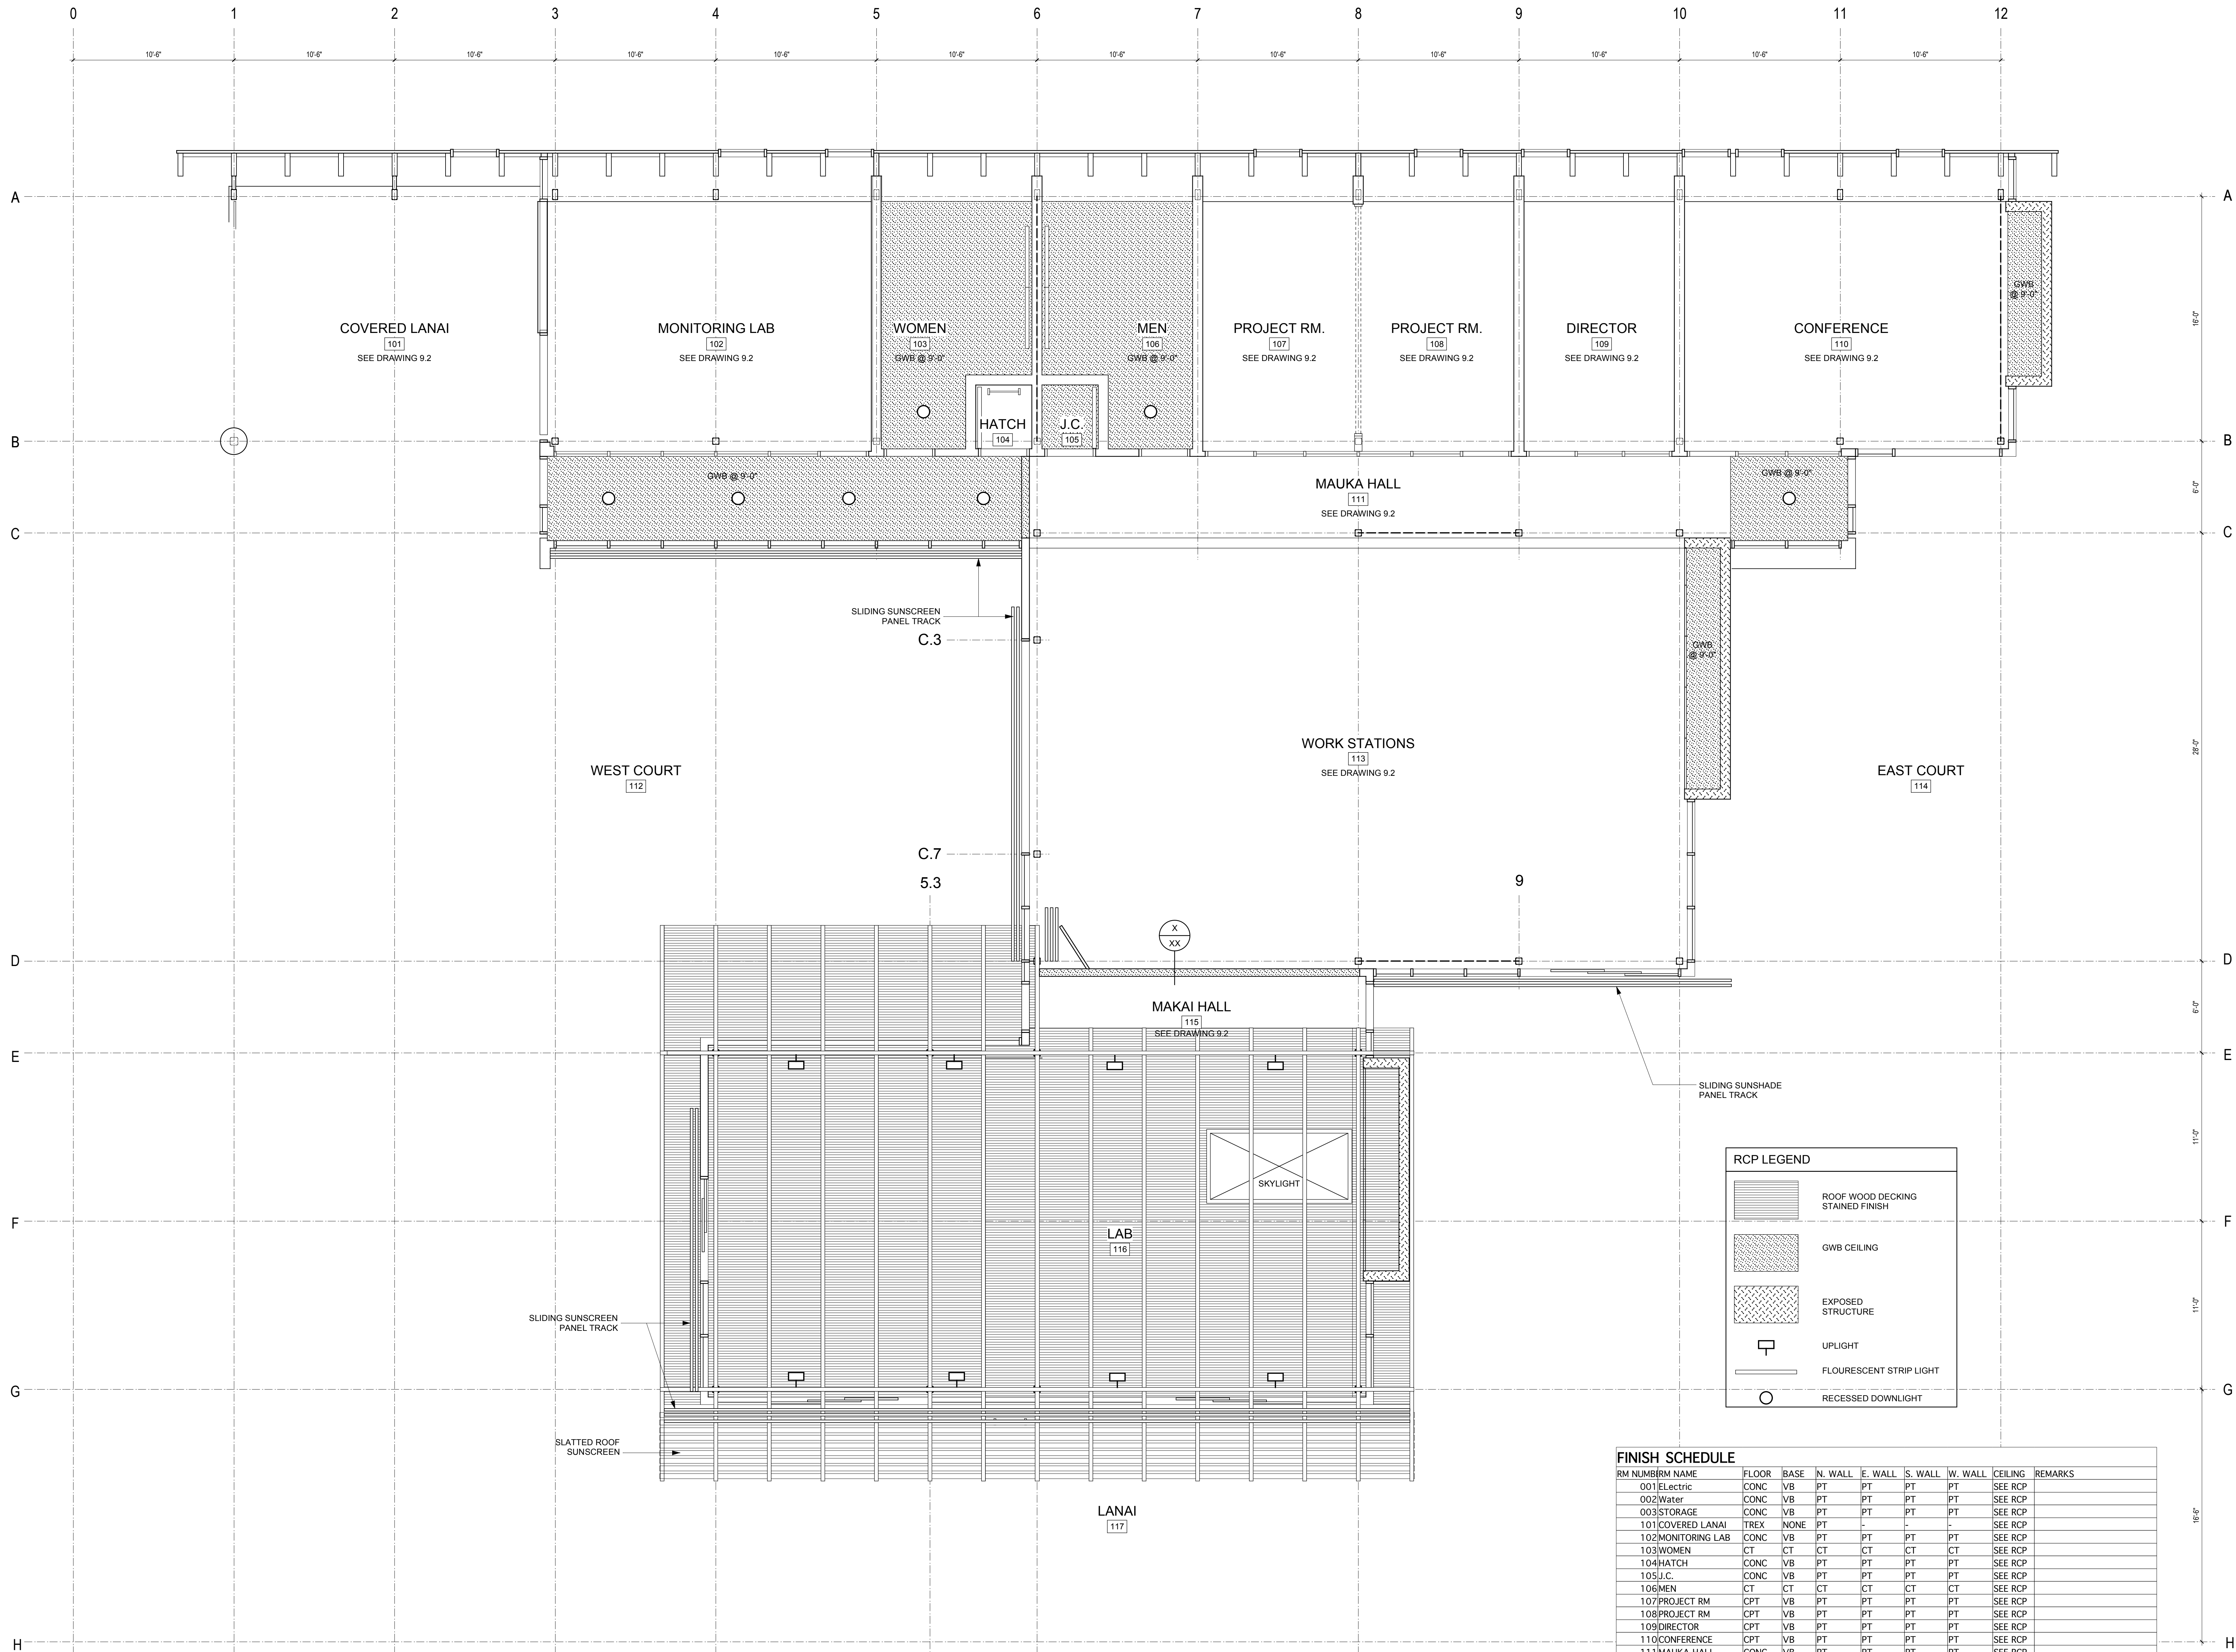


RCP LEGEND

- ROOF WOOD DECKING STAINED FINISH
- GWB CEILING
- EXPOSED STRUCTURE
- UPLIGHT
- FLOURESCENT STRIP LIGHT
- RECESSED DOWNLIGHT

FINISH SCHEDULE

RM NUMBER	RM NAME	FLOOR	BASE	N. WALL	E. WALL	S. WALL	W. WALL	CEILING	REMARKS
001	Electric	CONC	VB	PT	PT	PT	PT	SEE RCP	
002	Water	CONC	VB	PT	PT	PT	PT	SEE RCP	
003	STORAGE	CONC	VB	PT	PT	PT	PT	SEE RCP	
101	COVERED LANAI	TREX	NONE	PT	-	-	-	SEE RCP	
102	MONITORING LAB	CONC	VB	PT	PT	PT	PT	SEE RCP	
103	WOMEN	CT	CT	CT	CT	CT	CT	SEE RCP	
104	HATCH	CONC	VB	PT	PT	PT	PT	SEE RCP	
105	J.C.	CONC	VB	PT	PT	PT	PT	SEE RCP	
106	MEN	CT	CT	CT	CT	CT	CT	SEE RCP	
107	PROJECT RM	CPT	VB	PT	PT	PT	PT	SEE RCP	
108	PROJECT RM	CPT	VB	PT	PT	PT	PT	SEE RCP	
109	DIRECTOR	CPT	VB	PT	PT	PT	PT	SEE RCP	
110	CONFERENCE	CPT	VB	PT	PT	PT	PT	SEE RCP	
111	MAUKA HALL	CONC	VB	PT	PT	PT	PT	SEE RCP	
112	WEST COURT	CONC	NONE	-	-	-	-	SEE RCP	PROVIDE SCORES PER PLAN
113	WORK STATIONS	CPT	VB	PT	PT	PT	PT	SEE RCP	
114	EAST COURT	CONC	NONE	-	-	-	-	SEE RCP	PROVIDE SCORES PER PLAN
115	MAKAI HALL	CONC	VB	PT	PT	PT	PT	SEE RCP	
116	LAB	VB	PT	PT	PT	PT	PT	SEE RCP	
117	LANAI	TREX	NONE	-	-	-	-	SEE RCP	
201	MECHANICAL LOFT	NONE	PT	PT	PT	PT	PT	SEE RCP	

 

FIRST FLOOR REFLECTED CEILING PLAN

Drawn by: CB Job Number: 2804.00
Checked by: Scale: 1/4" = 1'-0"
Plot Date: Issue Date: 11 AUG 08

**A
9.1**